

① DOOR SCHEDULE


| MK | SIZE | DESCRIPTION |
|----|----------------------|-------------------------------|
| 1 | 3-0 X 8-0 X 1 3/4" | WOOD 6LT W/PNL BELOW, LOW E |
| 2 | 2-3-0 X 8-0 X 1 3/4" | 2 PANEL FIBERGLASS |
| 3 | 3-0 X 8-0 X 1 3/4" | 2 PANEL FIBERGLASS |
| 4 | 2-8 X 8-0 X 1 3/4" | 2 PANEL FIBERGLASS |
| 5 | 2-8 X 8-0 X 1 3/8" | 2 PANEL MASONITE |
| 6 | 2-4 X 6-0 | SEAMLESS GLASS SHOWER DOOR |
| 7 | 18-0 X 10-0 | METAL OVERHEAD GARAGE DOOR |
| 8 | 2-4 X 6-8 X 1 3/8" | 2 PANEL MASONITE |
| 9 | 2-8 X 6-8 X 1 3/8" | 2 PANEL MASONITE - SOLID CORE |

Ⓐ WINDOW SCHEDULE

| MK | SIZE | DESCRIPTION |
|----|-------------|-------------------------------------|
| A | 2-8 X 6-6 | VINYL AS SELECTED, S.H., BLT, LOW E |
| B | 2-1-6 X 6-6 | WOOD SHUTTERS |
| C | 2-0 X 4-0 | VINYL AS SELECTED, S.H., BLT, LOW E |
| D | 2-2-8 X 6-0 | VINYL AS SELECTED, S.H., BLT, LOW E |

NOTE: TEMPERED GLASS AS REQ'D PER CODE.


| SQ. FOOTAGE | PLANS FOR | NUMBER |
|----------------------|-------------------------------------|--------|
| IST FLOOR(STR) 1,079 | AARON AND ANDREA THOMAS | S-1789 |
| 2ND FLOOR 319 | | |
| TOTAL 1,398 | | |
| GAR/STOR(STR) 1,101 | DRAWN BY | SHEETS |
| PORCHES 220 | | |
| TOTAL 3,219 | ROYAL PLAN SERVICE LLC | 1 |
| DRAWN MCS | GEORGE E. PLAXCO, JR. - OWNER | 5 |
| CHECKED GEP, JR. | PHONE 368-6071 | |
| DATE 11/25/24 | 321 SOUTHFIELD ROAD SHREVEPORT, LA. | |

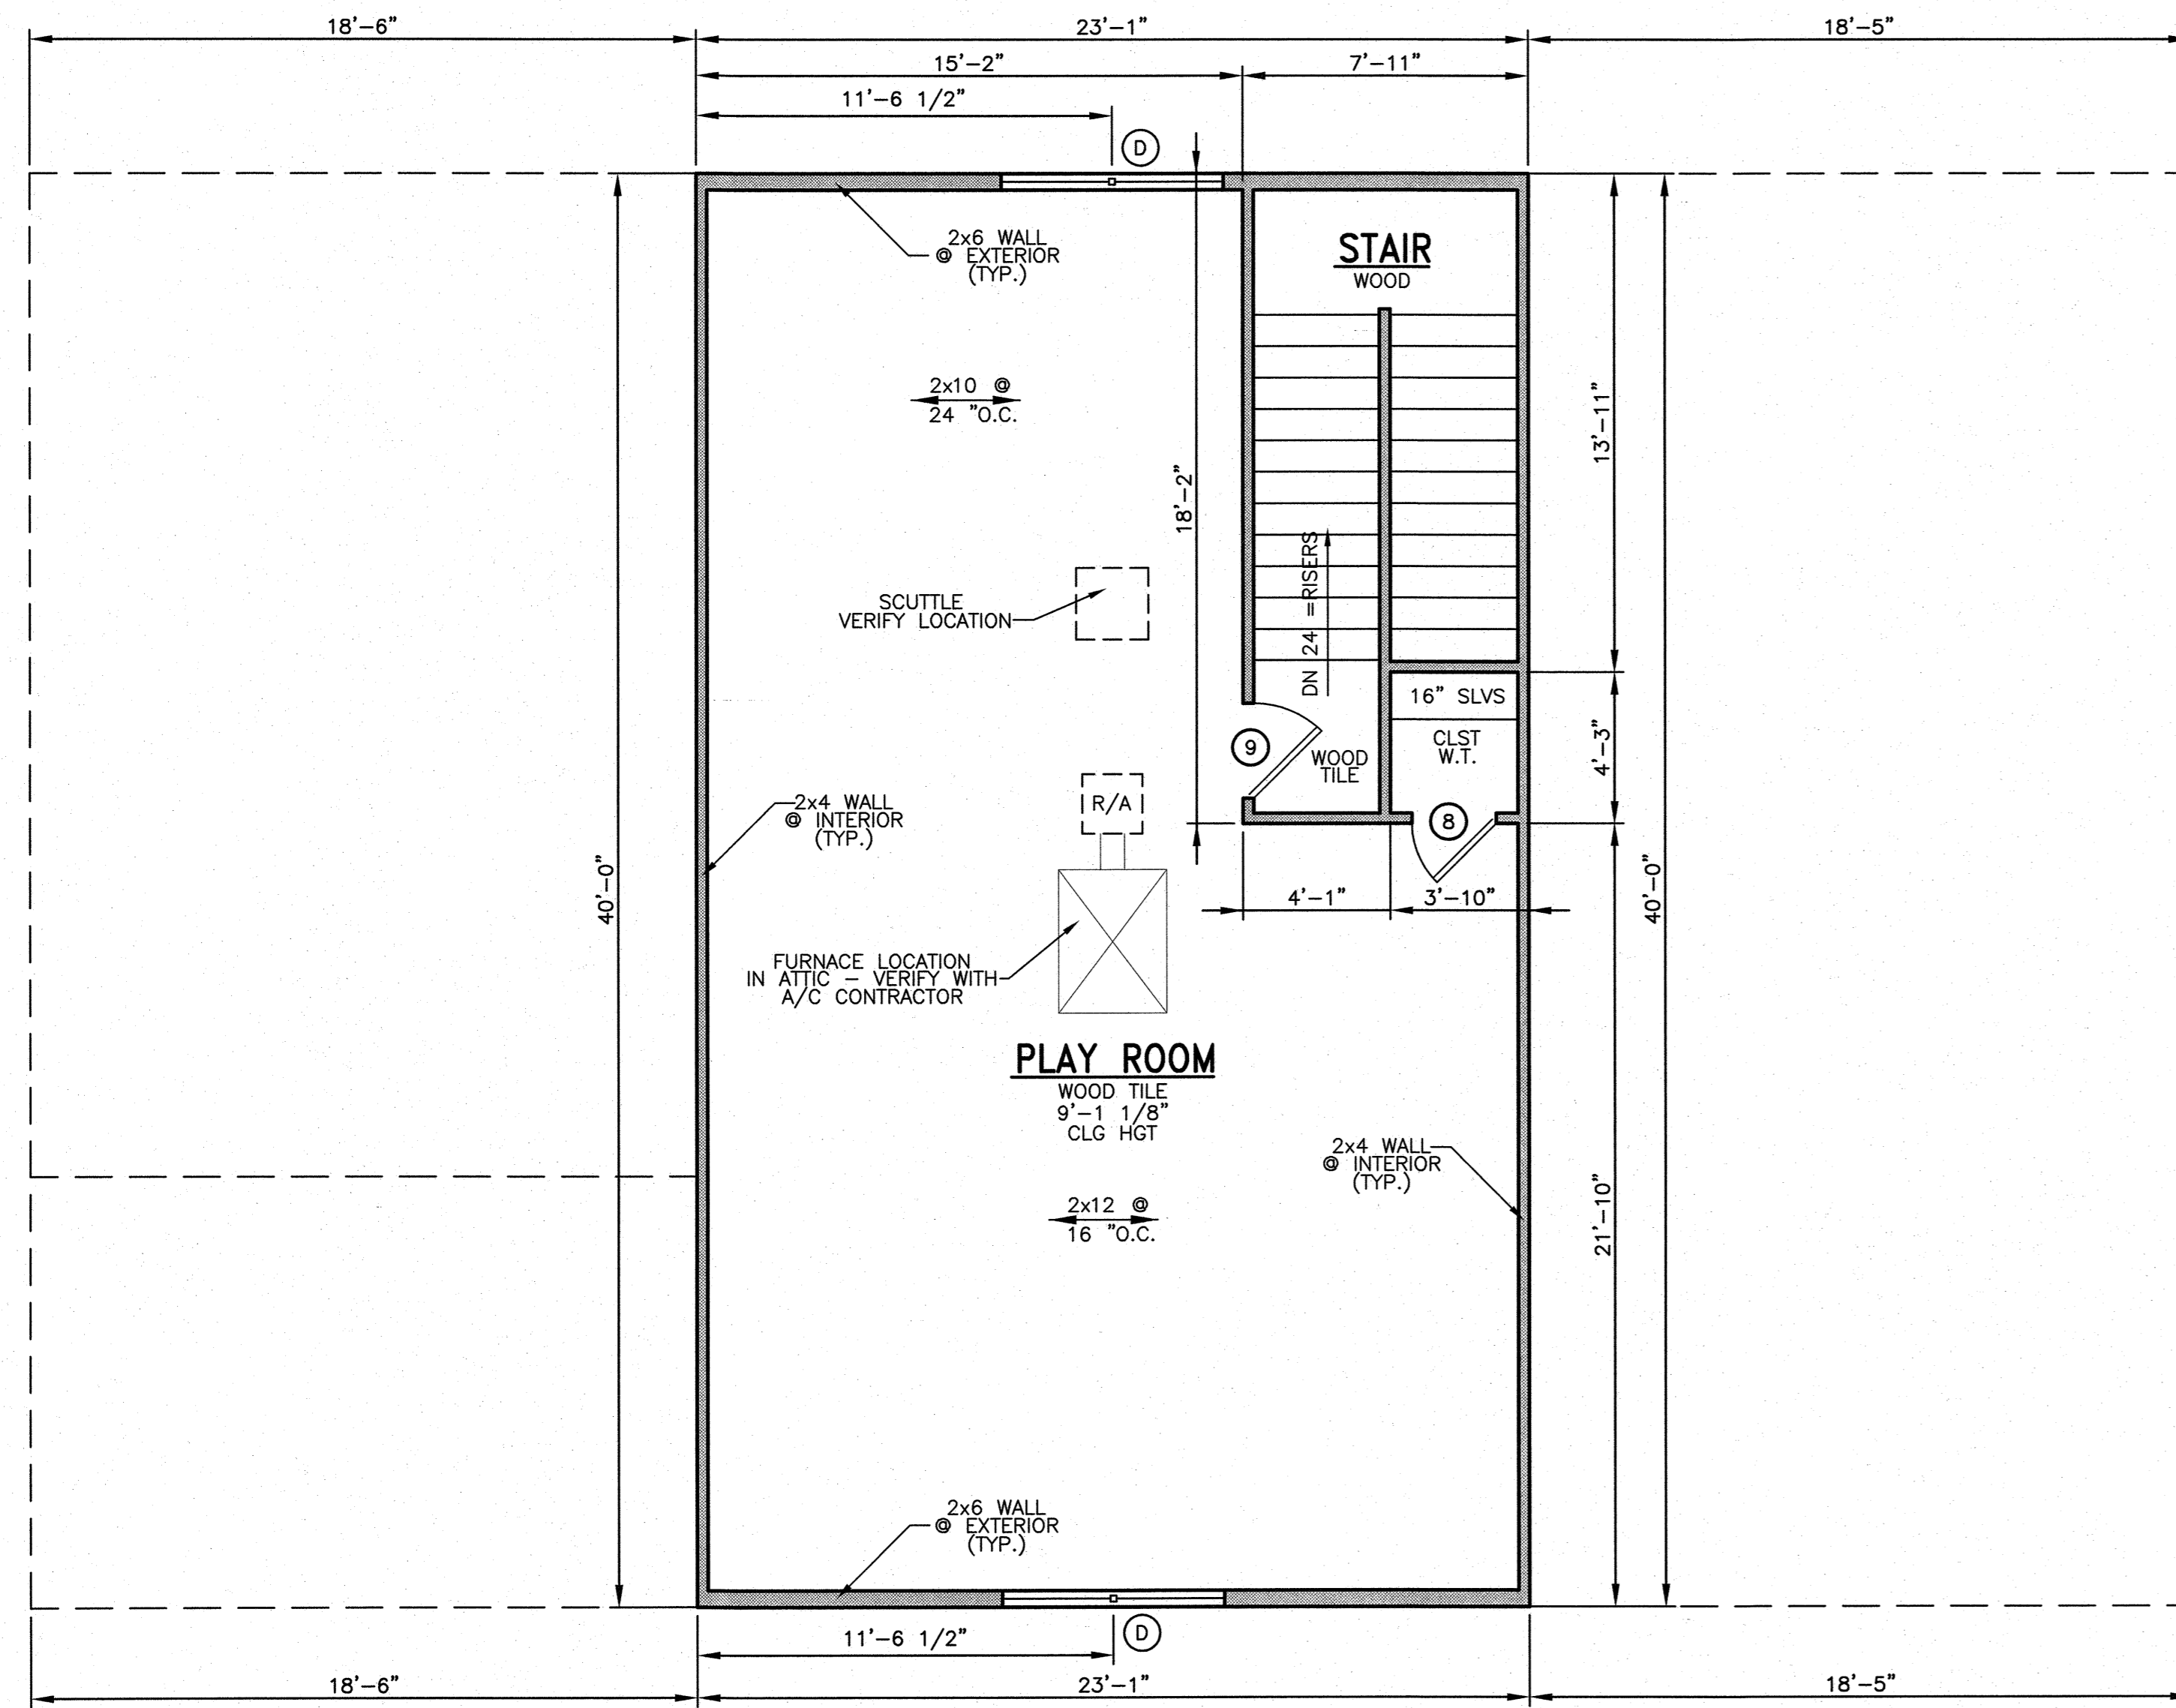

SECOND FLOOR PLAN

SCALE 1/4" = 1'-0"


- NOTES:
1. 9'-1 1/8" CLG HT UNLESS NOTED OTHERWISE.
 2. 1 TANKLESS GAS WATER HEATER - VERIFY LOCATION
 3. PROVIDE 24" WIDE WALKWAY TO A/C UNITS & W/H
 4. VERIFY ALL ELECTRICAL W/ OWNER
 5. VERIFY ALL FLOOR TRUSSES/GLUE-LAM BEAMS W/ENGINEER.
 6. 1-5 TON & 1-2 TON A/C UNIT - VERIFY W/ A/C CONTRACTOR
 7. VERIFY APPLIANCE ACCESS ON SITE

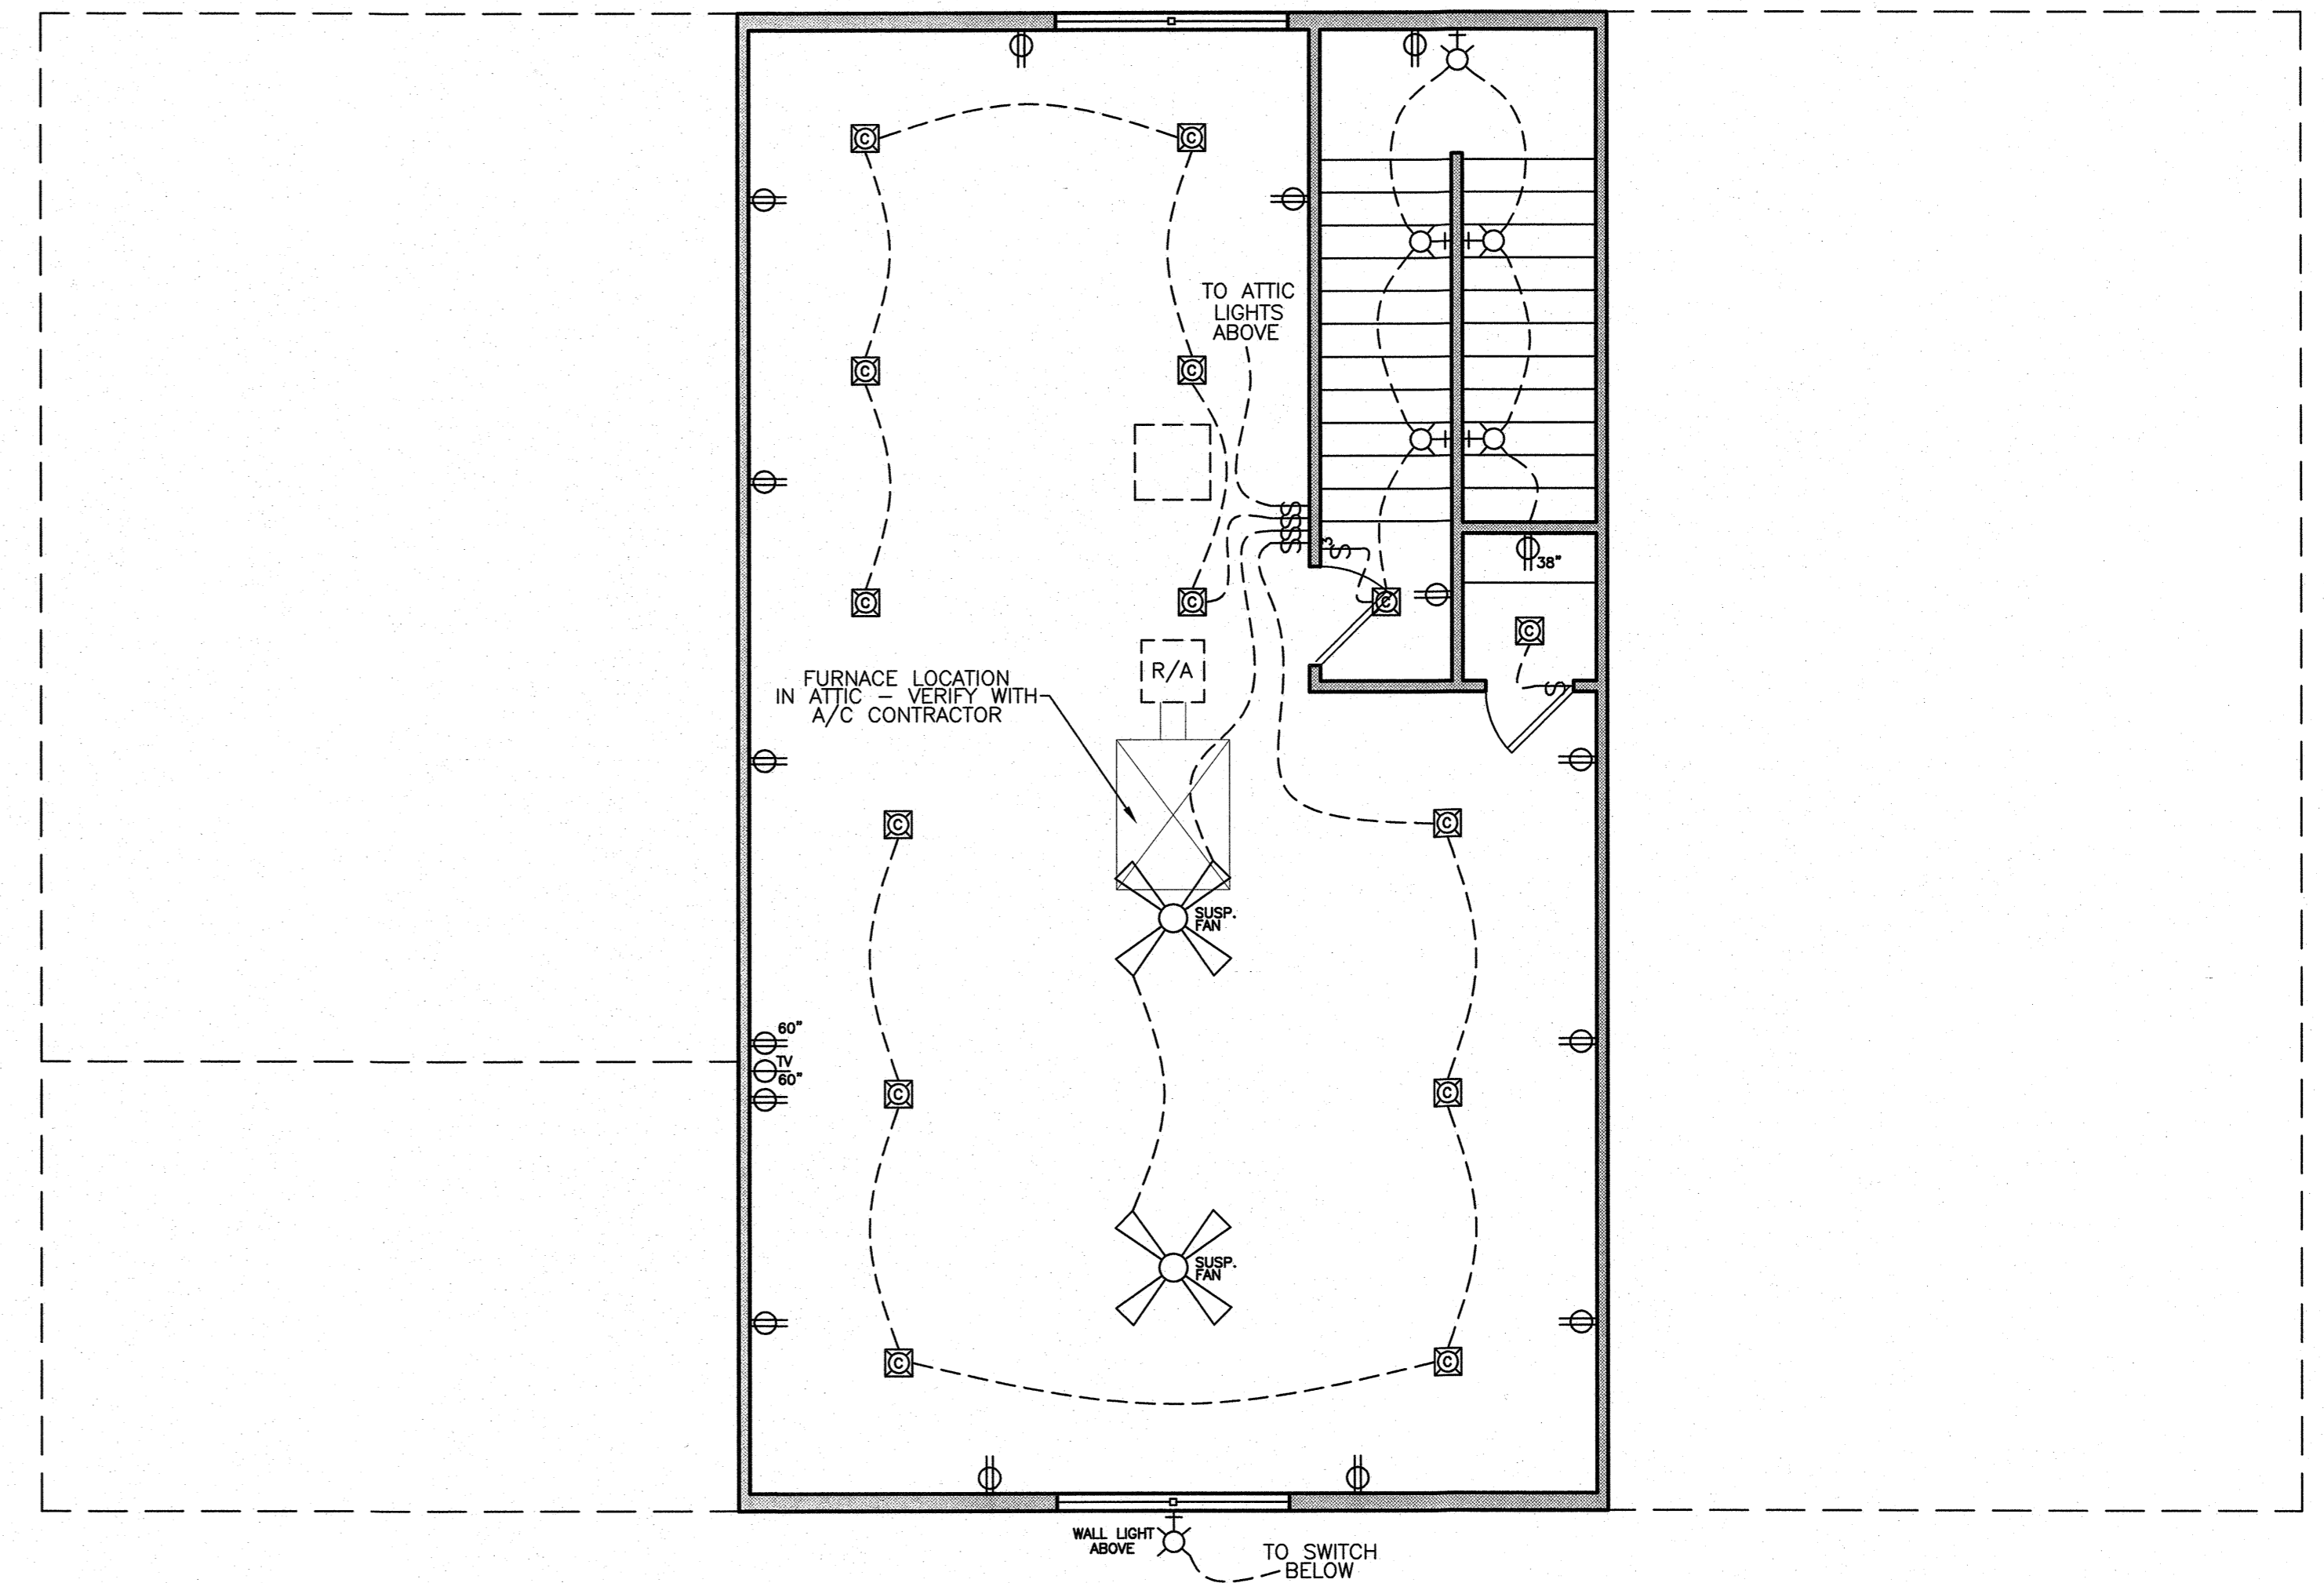

SECOND FLOOR ELECTRICAL PLAN

SCALE 1/4" = 1'-0"


| SQ. FOOTAGE | PLANS FOR | NUMBER |
|----------------------|-------------------------------------|--------|
| 1ST FLOOR(STR) 1,079 | AARON AND ANDREA THOMAS | S-1789 |
| 2ND FLOOR 819 | | |
| TOTAL 1,898 | | |
| GAR(STOR)(STR) 1,101 | DRAWN BY | SHEETS |
| PORCHES 220 | | |
| TOTAL 3,219 | ROYAL PLAN SERVICE LLC | 2 |
| DRAWN MCS | GEORGE E. PLAXCO, JR. - OWNER | 5 |
| CHECKED GEP, JR. | 321 SOUTHFIELD ROAD SHREVEPORT, LA. | |
| DATE 11/25/24 | | |

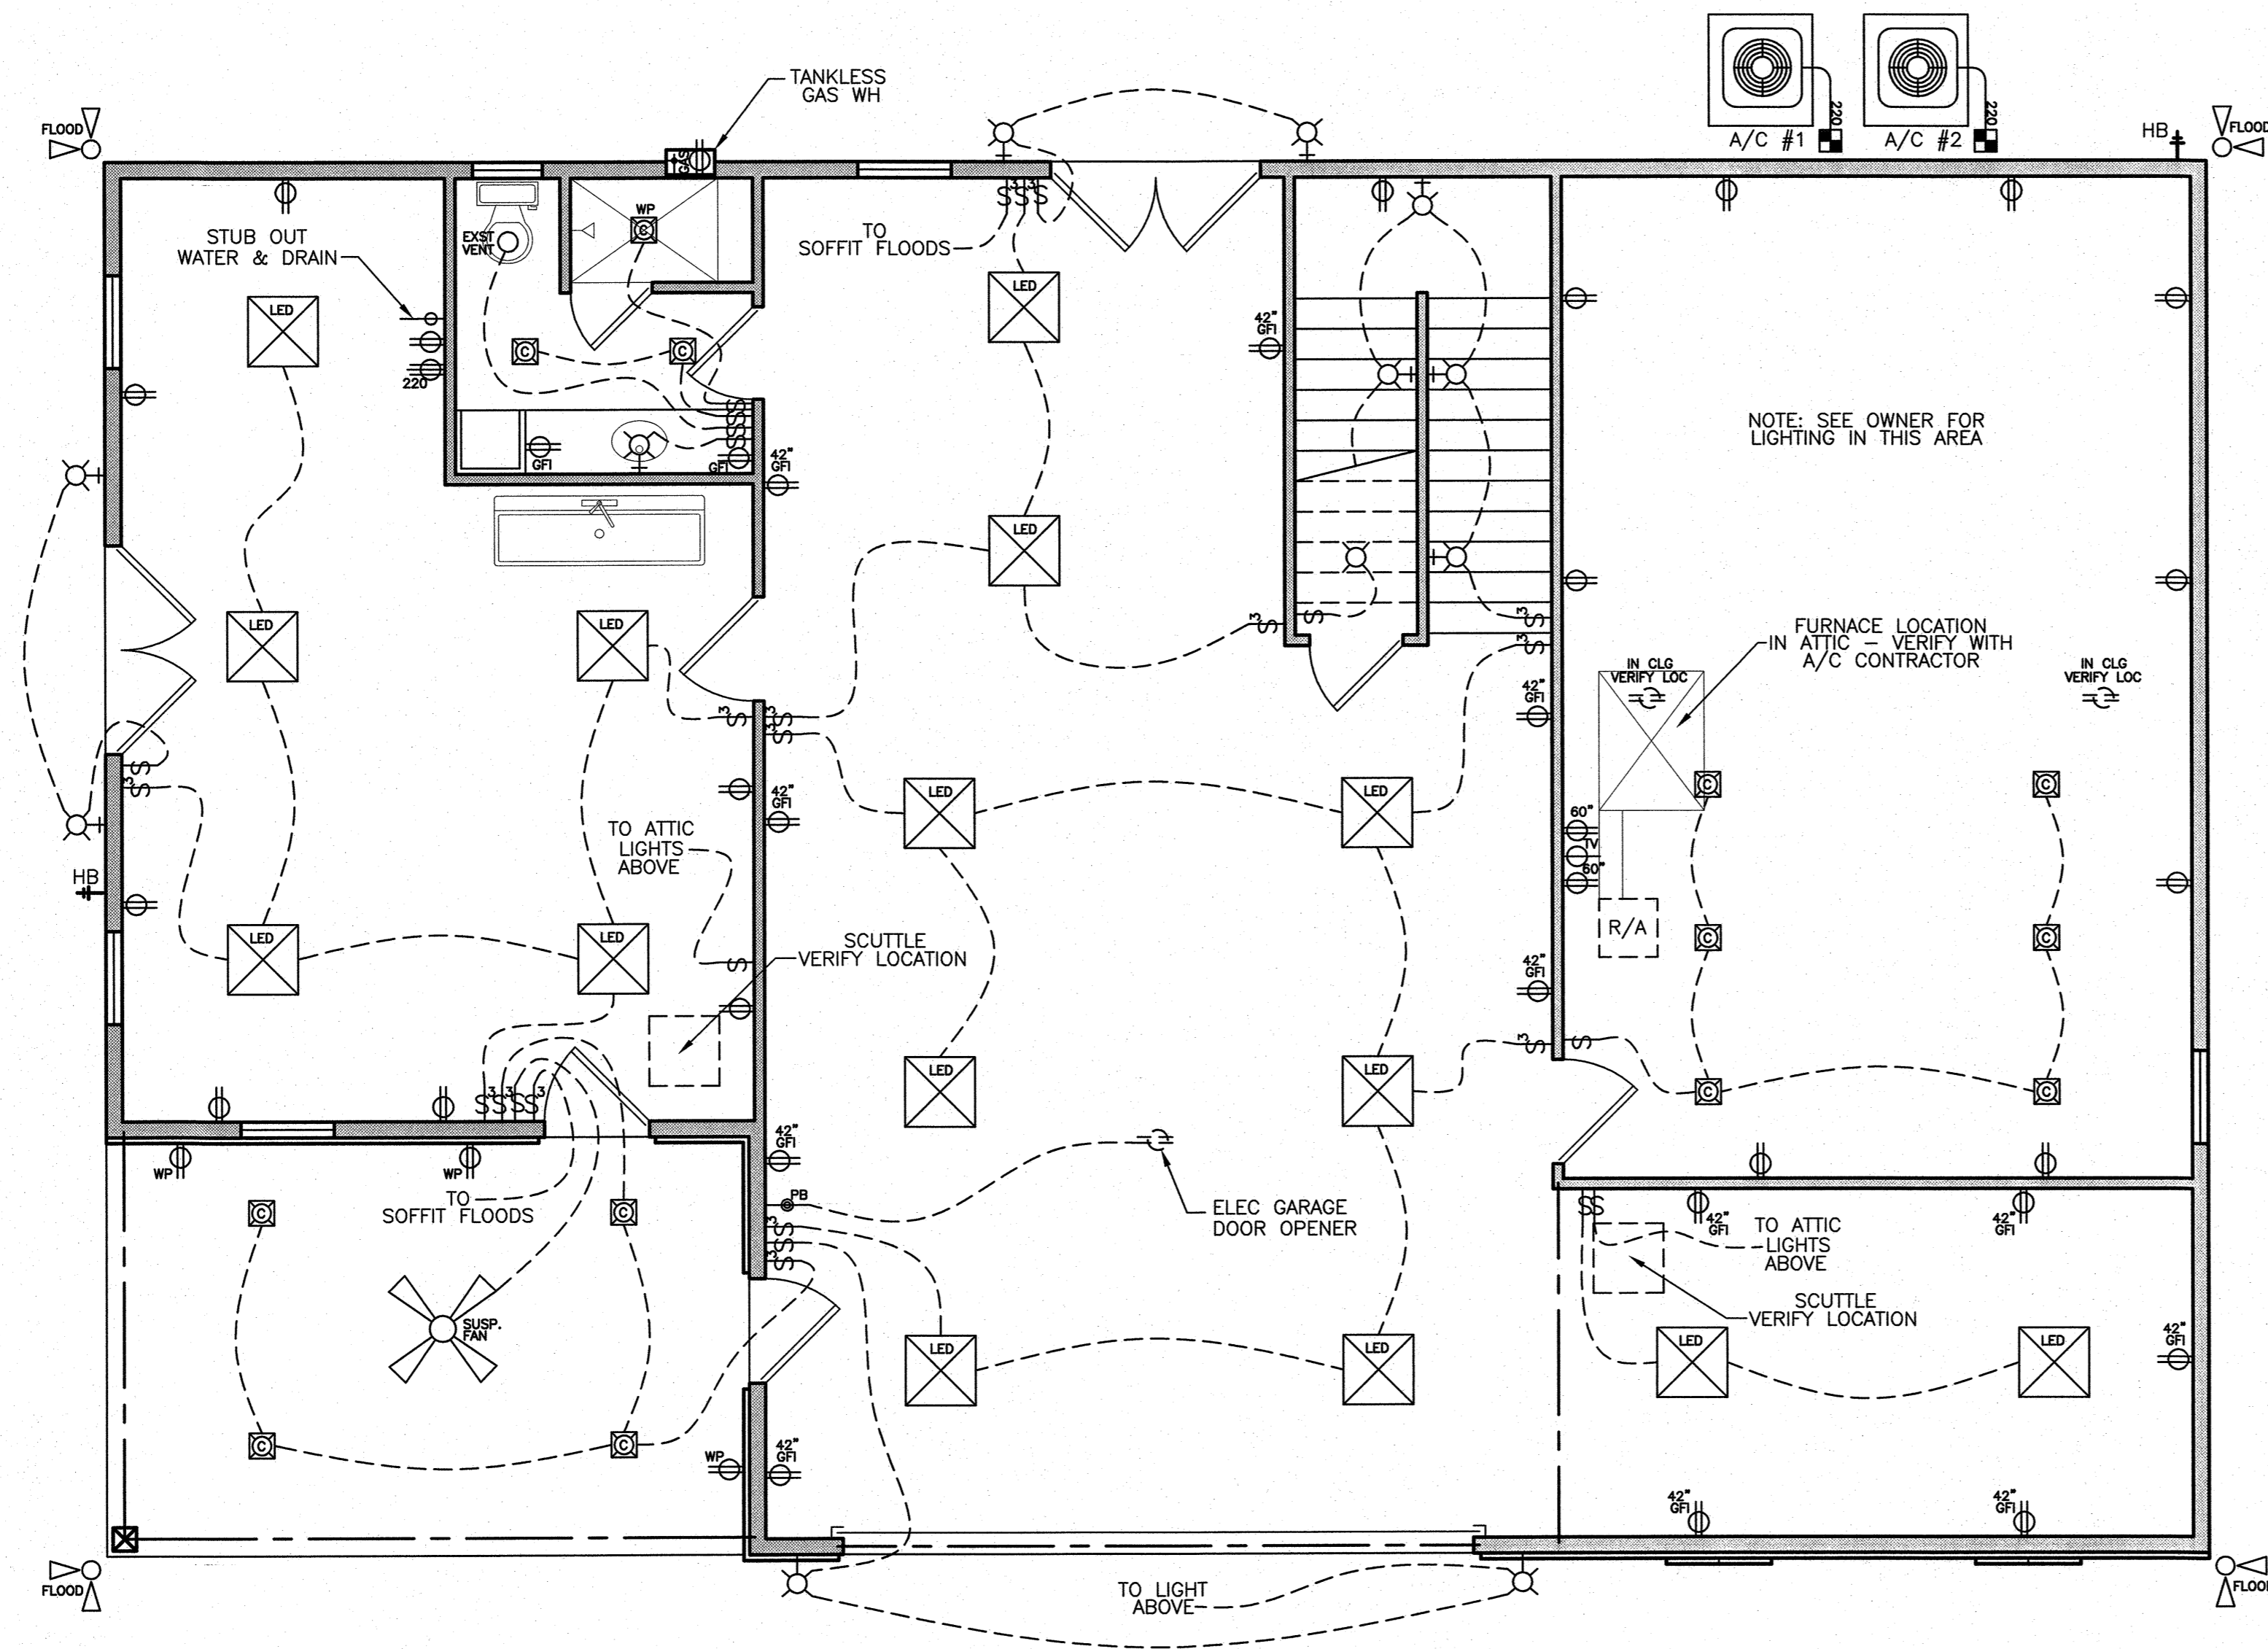


FIRST FLOOR ELECTRICAL PLAN

SCALE 1/4" = 1'-0"

| | | |
|--|-------------------------|--------|
| | PLANS FOR | NUMBER |
| | AARON AND ANDREA THOMAS | S-1789 |
| | DRAWN BY | SHEETS |
| ROYAL PLAN SERVICE LLC | 3 | 5 |
| GEORGE E. PLAXCO, JR. - OWNER PHONE 868-6071 321 SOUTHFIELD ROAD - SHREVEPORT, LA. | | |

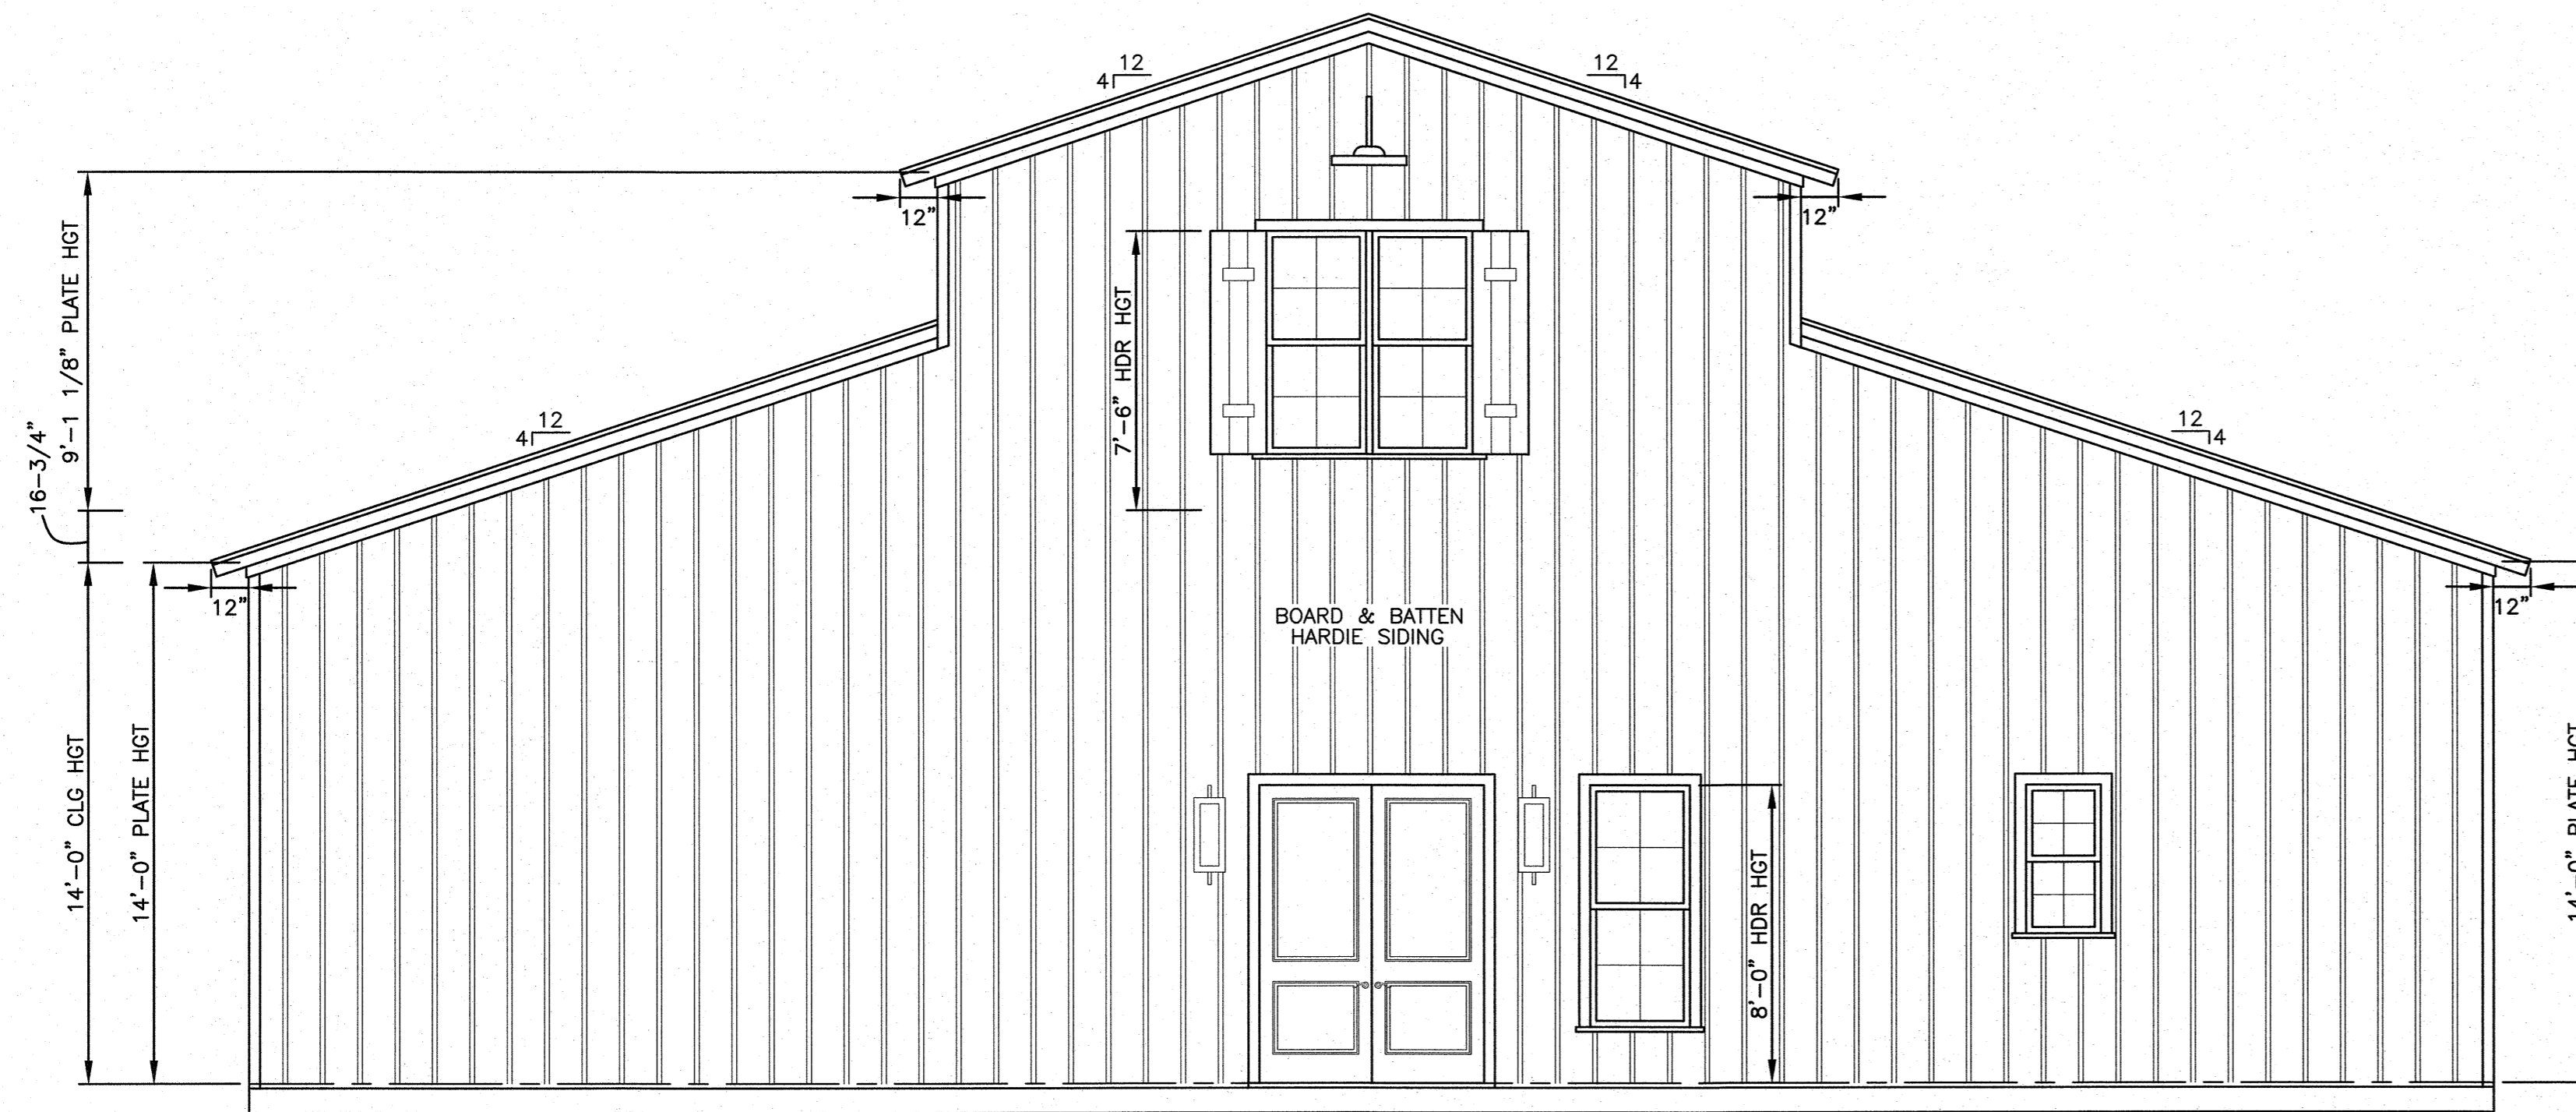


REAR ELEVATION
1/4"=1'-0"

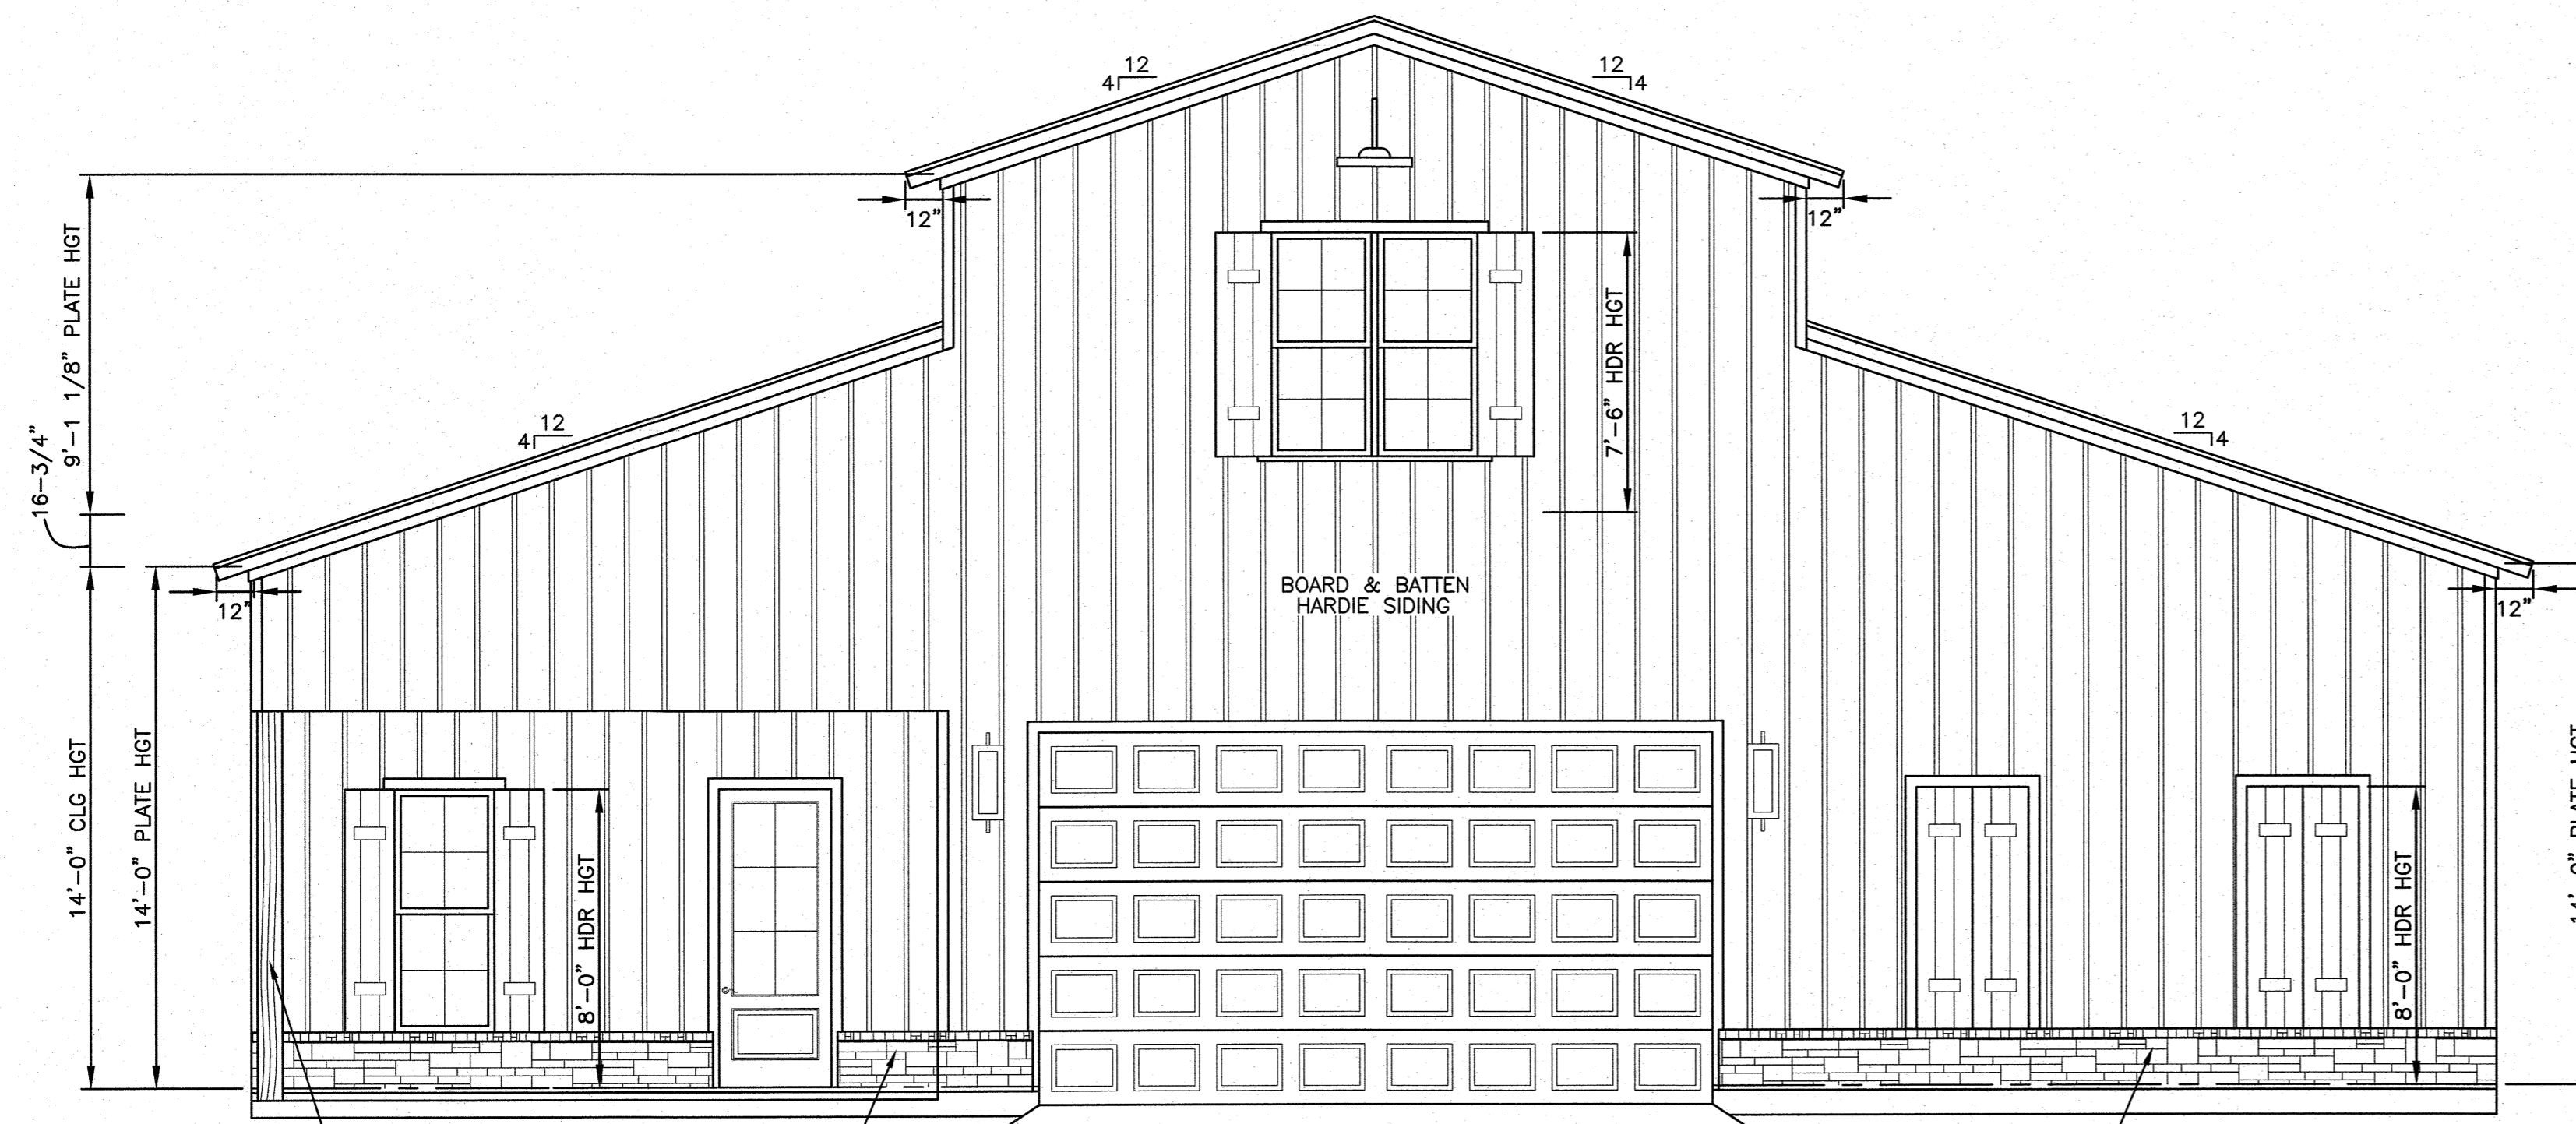

8x8 TIMBER POST
18" STONE VENEER WAINSCOT W/ BOARD & BATTEN HARDIE SIDING ABOVE

FRONT ELEVATION
1/4"=1'-0"


18" STONE VENEER WAINSCOT W/ BOARD & BATTEN HARDIE SIDING ABOVE

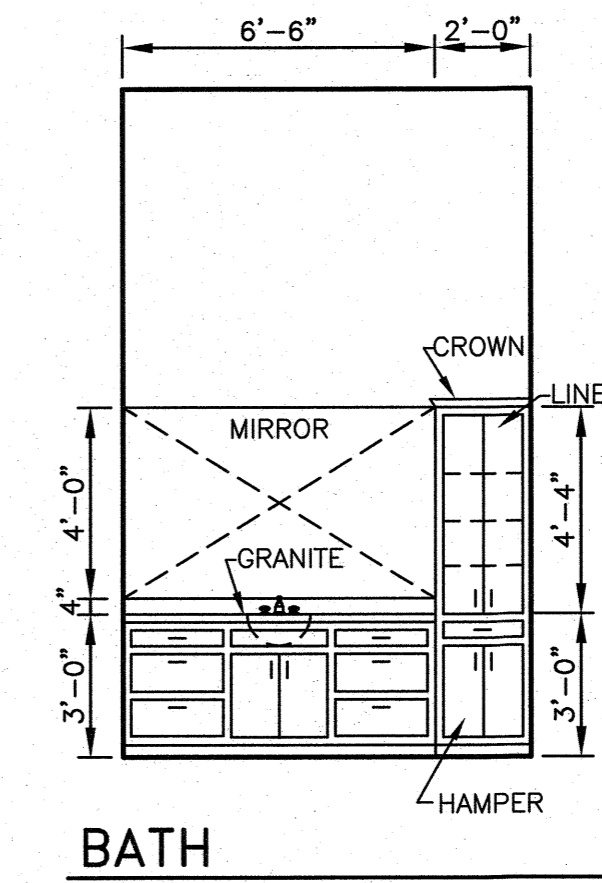


BATH
CABINET ELEVATIONS

SCALE 1/4" = 1'-0"
NOTES:
1. VERIFY ALL DESIGN WITH OWNER
2. VERIFY SIZES ON JOB.

| | | |
|---|--|--------|
| PLANS FOR AARON AND ANDREA THOMAS | NUMBER | S-1789 |
| | DRAWN BY ROYAL PLAN SERVICE LLC <small>GEORGE E. PLAXCO, JR. - OWNER PHONE 868-6071 321 SOUTHFIELD ROAD SHREVEPORT, LA.</small> | SHEETS |

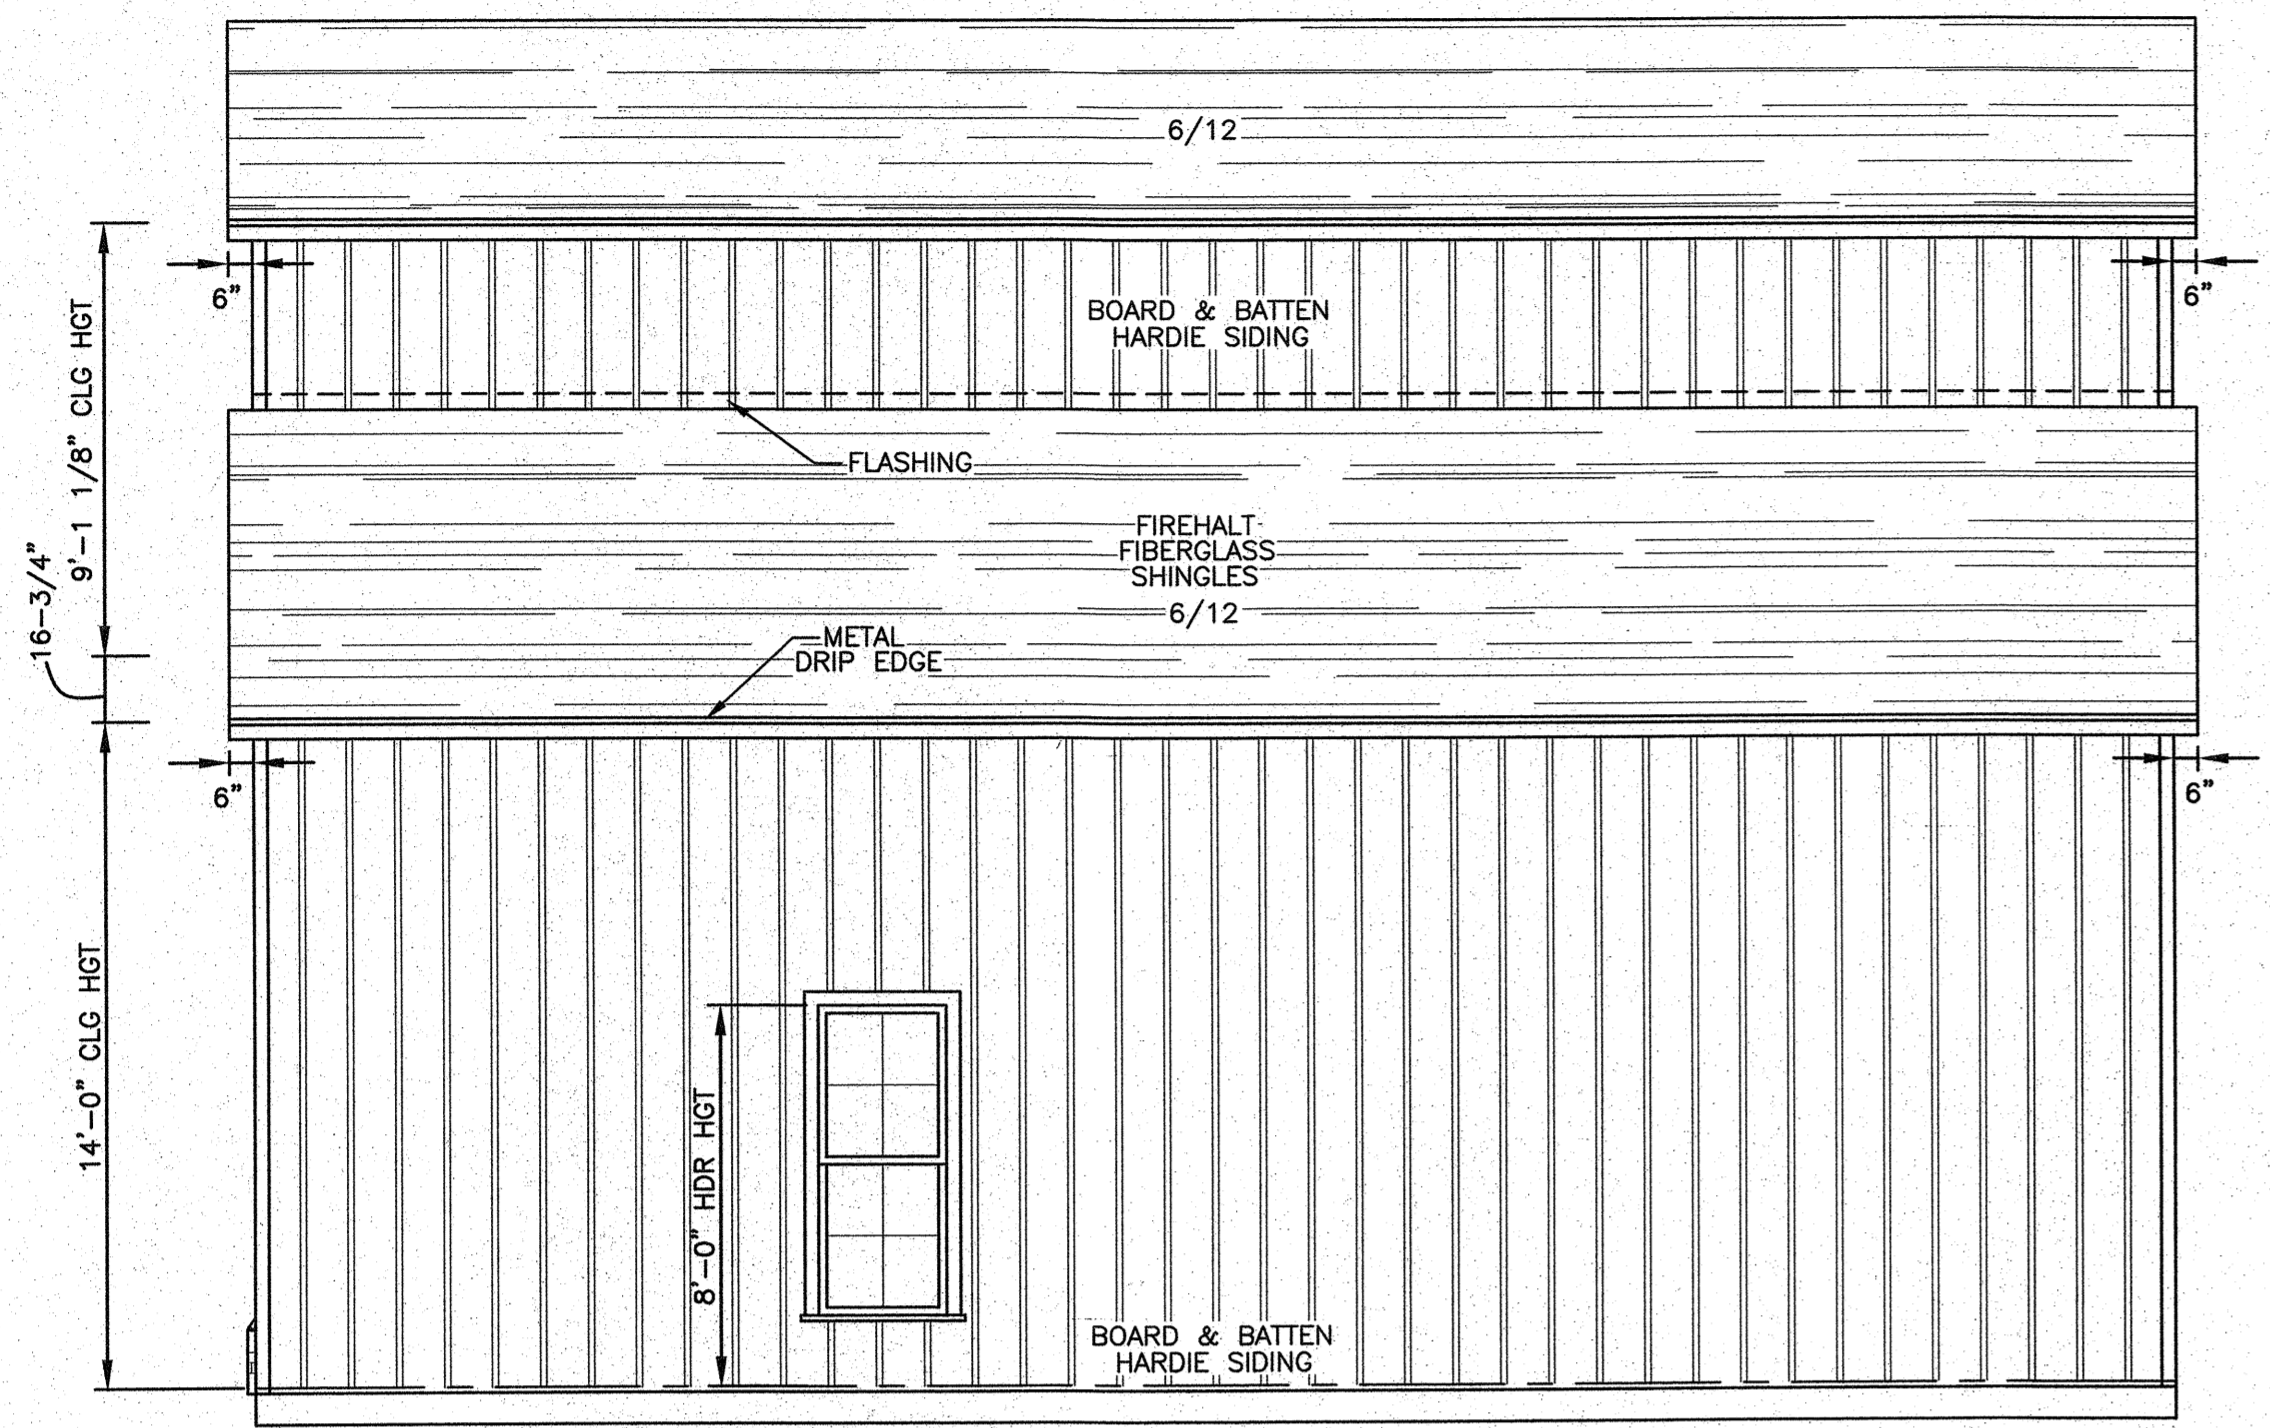


RIGHT ELEVATION
1/4"=1'-0"

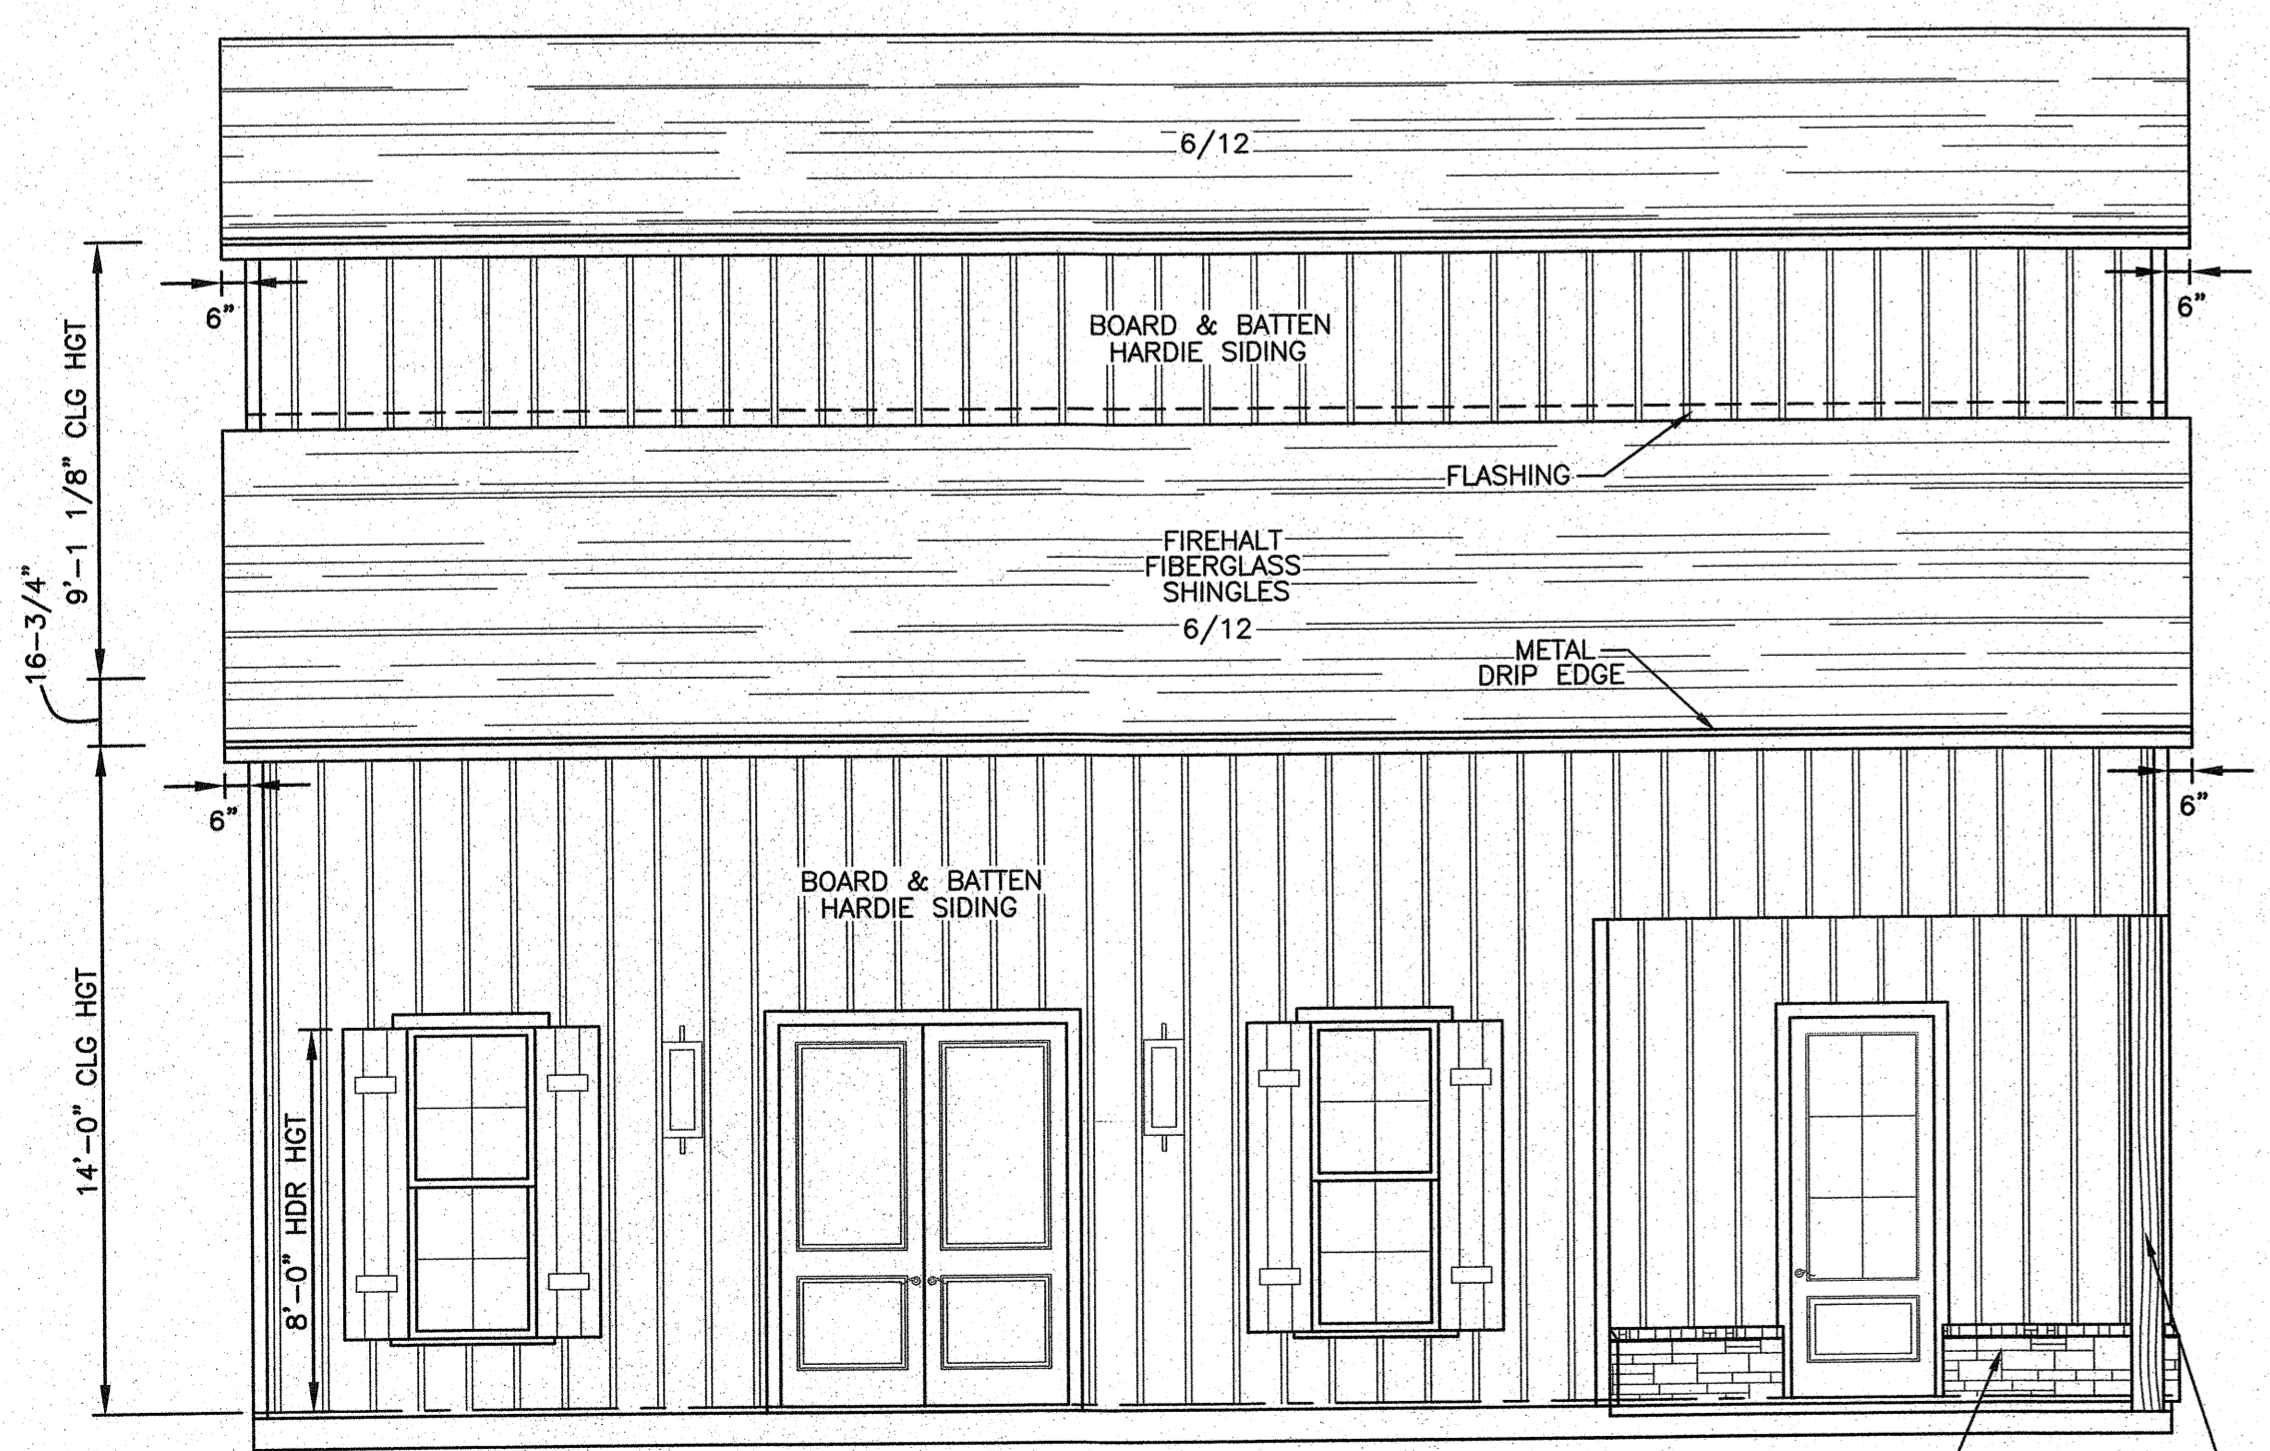

LEFT ELEVATION
1/4"=1'-0"

18" STONE VENEER WAINSCOT W/ BOARD & BATTEN HARDIE SIDING ABOVE
8X8 TIMBER POST

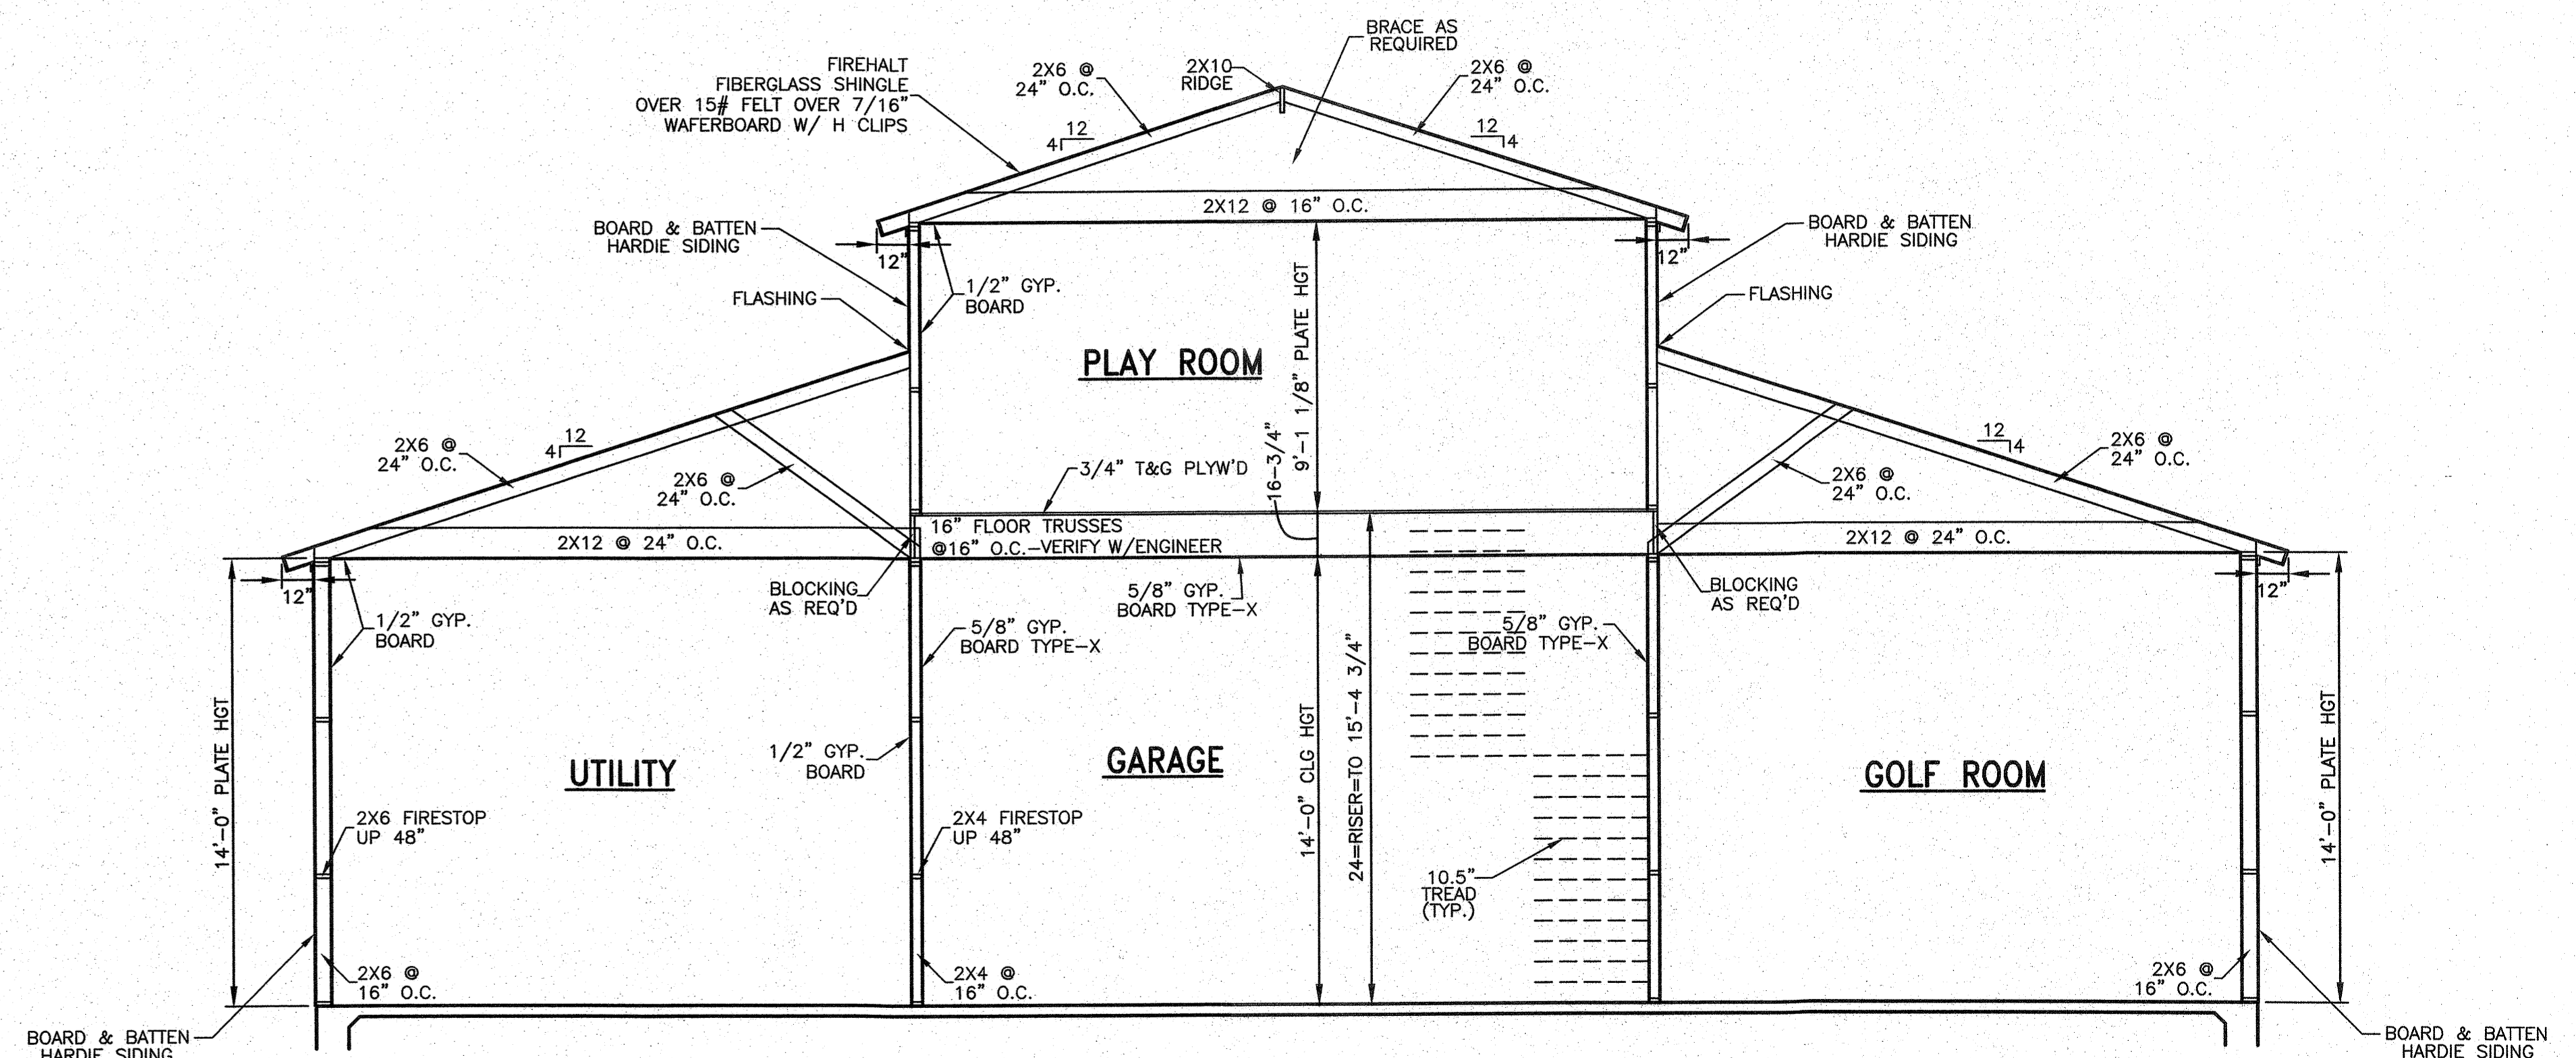

CROSS SECTION
1/4"=1'-0"

NOTE: FIRERATED SHEET ROCK @ GARAGE & PLAY RM AS PER CODE

| | | |
|--|--|--------|
| PLANS FOR | | NUMBER |
| AARON AND ANDREA THOMAS | | S-1789 |
| DRAWN BY | | SHEETS |
| ROYAL PLAN SERVICE LLC | | 5/5 |
| GEORGE E. PLAXCO, JR. - OWNER PHONE 888-6071 321 SOUTHFIELD ROAD SHREVEPORT, LA. | | |

